




Front Elevation

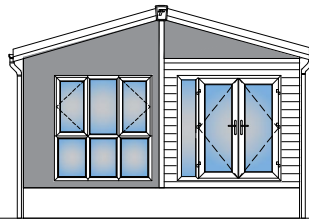

End Elevation (Lounge)

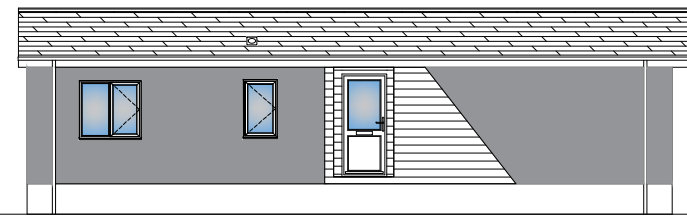


Rear Elevation

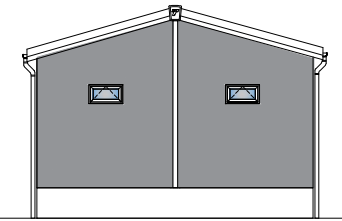

End Elevation (Bedroom)

Elevations Are For Illustrative Purposes Only

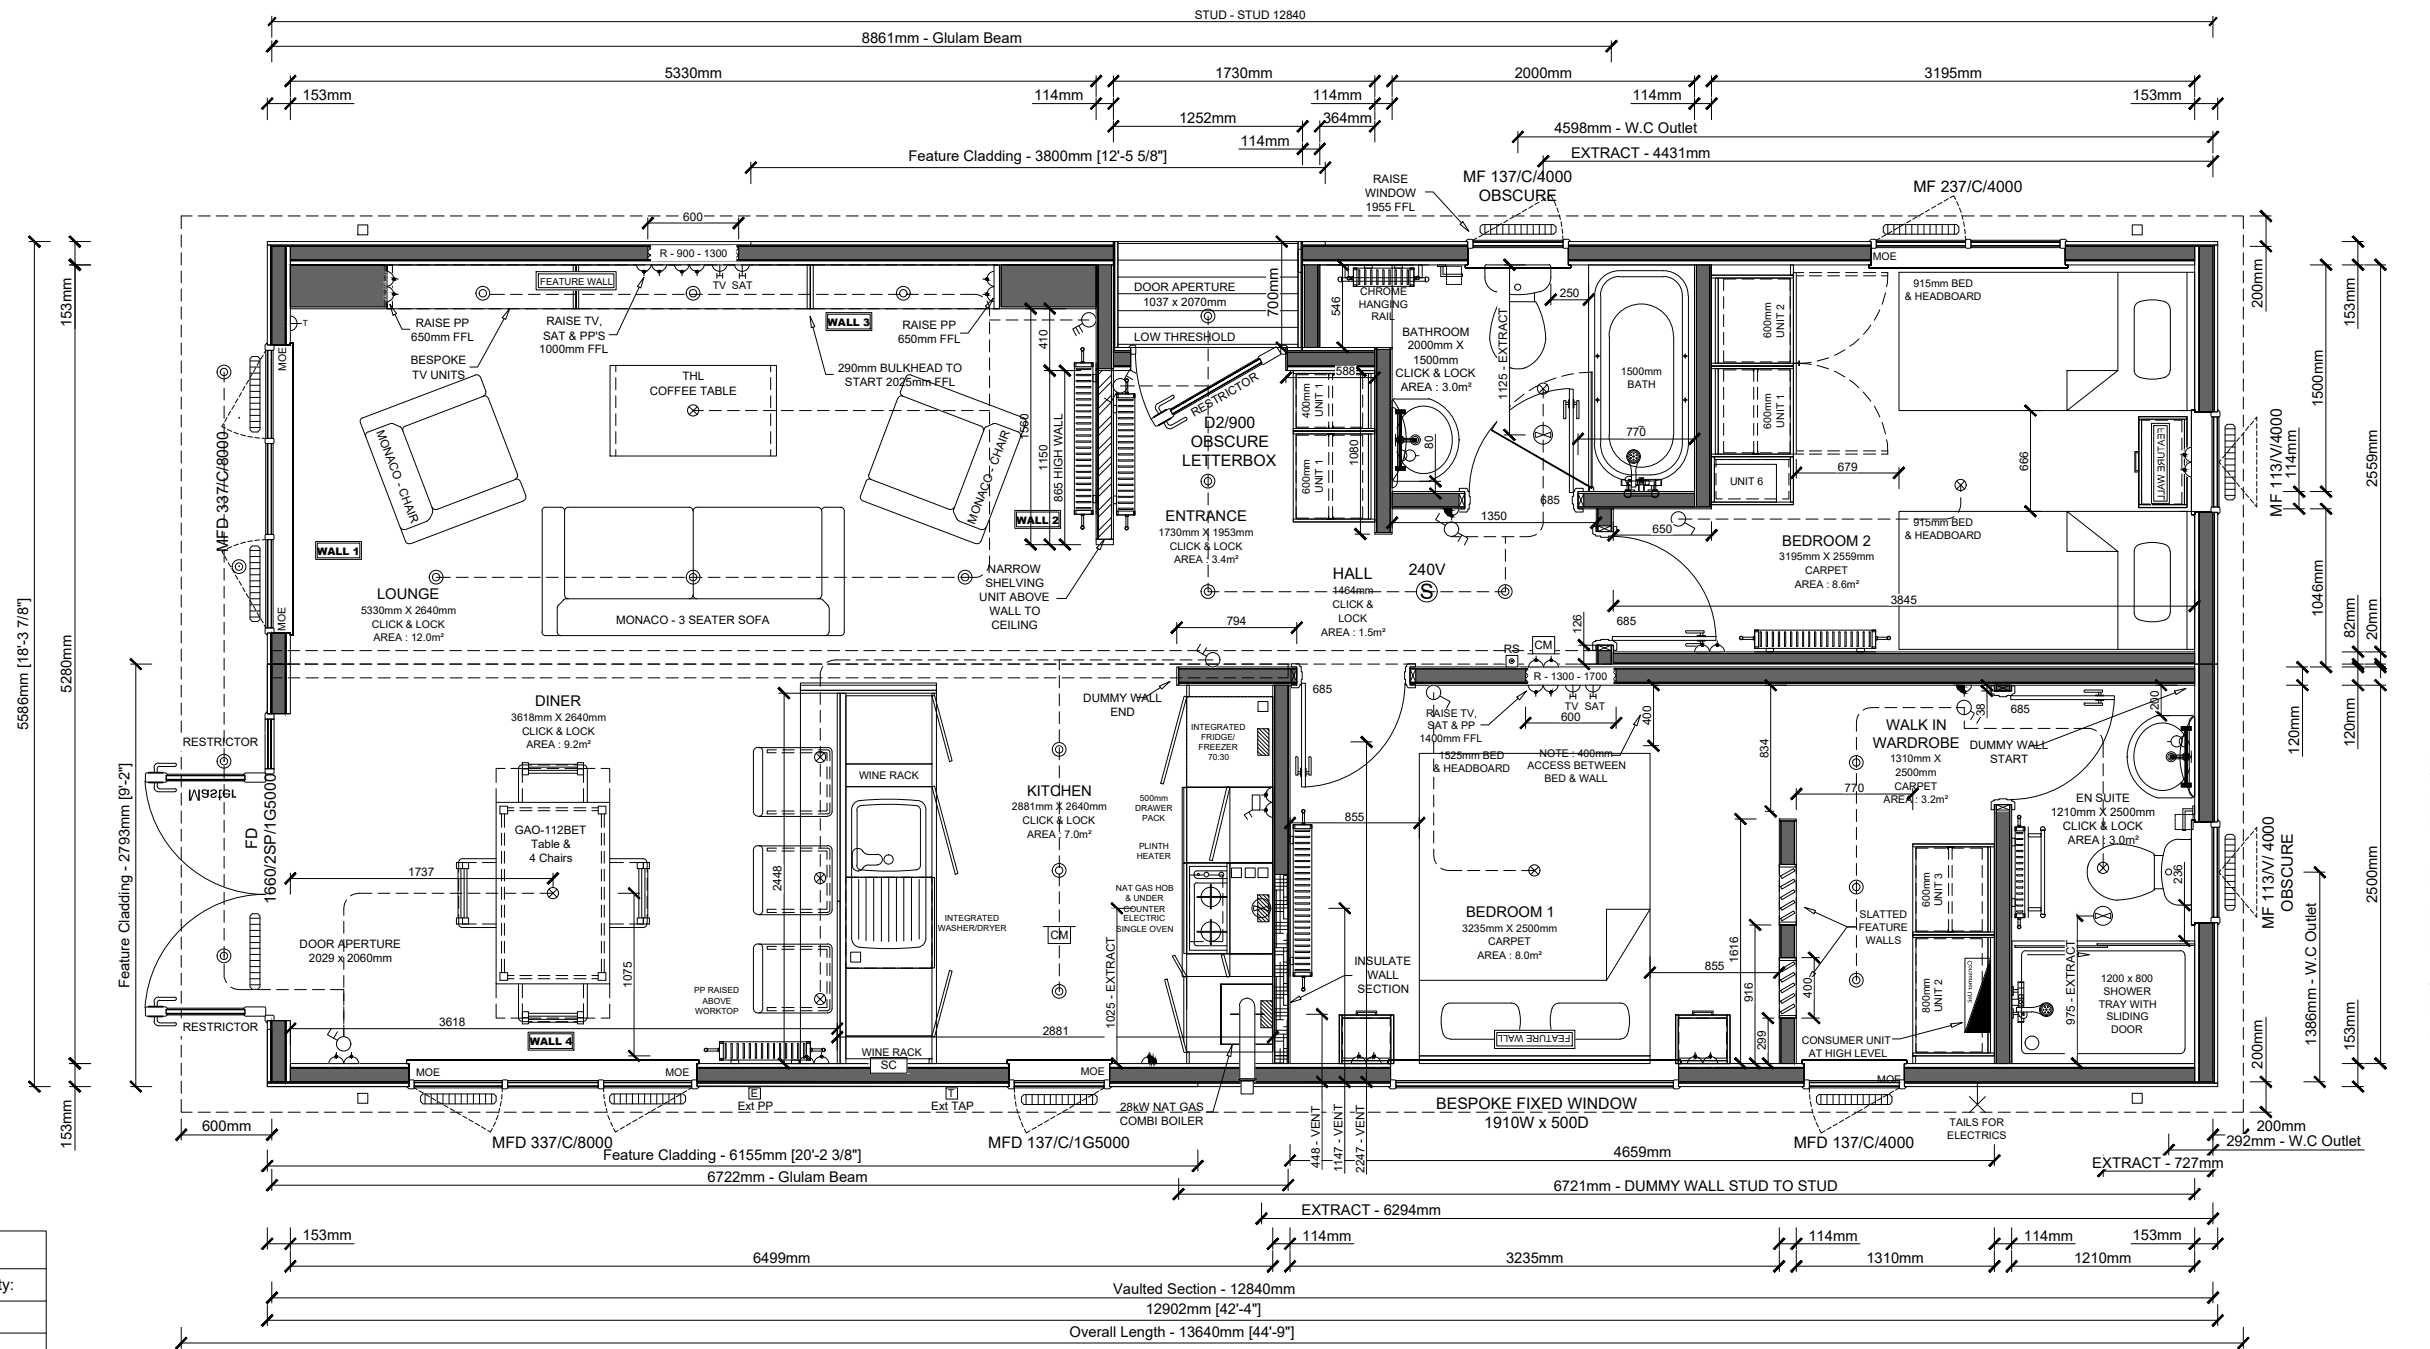

Roof Trusses	
Code:	Quantity:
TBC V	64
TBC V (M)	4

Support Drawings	
Description	DWG No.
W. Set. Out	200375_S
Vaulted Walls	200375_VW
Vault Lights	200375_VL
Roof Extract	200375_RE
Tiled Walls	200375_TW
Roof Plan	200375_RP
Electric Plan	200375_EP
Plumbing Plan	200375_PS
Shelves	200375_S
Bed 1 Furn.	200375_B1
Lounge Alcove	200375_LA
Bench	200375_B

Transport Dimensions:	
Note: Weights are for Guidance ONLY	
Height:	3.988
Width N/S:	3.087
Weight N/S:	7.917
Width O/S:	3.087
Weight O/S:	7.482
Band: F	Axles: 3

Symbol	Description	Symbol	Description	Symbol	Description	Symbol	Description
[Symbol]	DOUBLE SWITCHED SOCKET	[Symbol]	ELECTRIC TAILS ONLY	[Symbol]	240v	[Symbol]	SMOKE DETECTOR
[Symbol]	SINGLE SWITCHED SOCKET	[Symbol]	PENDANT LIGHT FITTING	[Symbol]	ELECTRICAL CONSUMER UNIT	[Symbol]	MEANS OF ESCAPE WINDOW VENT
[Symbol]	LIGHT SWITCH	[Symbol]	BATTEN LIGHT FITTING	[Symbol]	EXTERNAL POWER POINT	[Symbol]	
[Symbol]	LIGHT SWITCH PULL CORD	[Symbol]	TELEPHONE POINT	[Symbol]	EXTERNAL LIGHT FITTING	[Symbol]	
[Symbol]	FUSED SPUR	[Symbol]	TELEVISION OR SATELLITE POINT	[Symbol]	SWITCHING CENTER	[Symbol]	
[Symbol]	COOKER SWITCH	[Symbol]	CARBON MONOXIDE DETECTOR	[Symbol]	WASHING MACHINE PLUMBING	[Symbol]	
[Symbol]	DOWNLIGHT	[Symbol]	HEATING THERMOSTAT	[Symbol]	RADIATOR	[Symbol]	
[Symbol]	WALL LIGHT	[Symbol]	EXTRACTOR FAN	[Symbol]	EXTERNAL TAP	[Symbol]	

Radiator Schedule	
LOUNGE	SD 60 100
DINER	SD 60 60
KITCHEN	PLINTH HEATER
BATHROOM	SD 60 40
BED 1	SD 60 100
BED 2	SD 60 80
ENSUITE	SS 60 60
ENTRANCE	SD 60 80

TRV's To All Rads Except Entrance

Build Notes:
 16° PITCH ROOF
 VAULTED CEILING THROUGHOUT
 4X STEEL BEAMS & 2X GLULAM BEAMS REQUIRED

Copyright Notice:
 This drawing and the information contained in it, is the property of Tingdene Homes Ltd. It may not be used, transmitted or reproduced, in whole or in part, without prior written consent from Tingdene Homes Ltd. Copyright ©.

Model:	HARRINGTON	
Size:	Metric: 12.902m x 5.586m	Imperial: 42'4" x 18'3"
Park:	SOUTHEAST PARKS	
Customer:	STOCK	

Date Drawn:	05.01.21	By:	MD
A	14.01.21 - MH	B	16.02.21 - TD
C	17.02.21 - TD	D	25.02.21 - MD
E	---	F	---

TINGDENE
 Discover the difference

Tingdene Homes Limited.
 Bradfield Road, Finedon Road Ind. Est., Wellingborough,
 Northants, NN8 4HB
 Tel: +44(0)1933 230100
 www.tingdene.co.uk

Scale:	1:50	Sales No:	Q20000329	S.O. No:	200375_P
--------	------	-----------	-----------	----------	----------